


ITEM	QTY	DESCRIPTION	DETAIL	PROTEA STOCK NO
1	1	CASE	TBA	ENC-TR-002
2	1	FRONT PANEL	DKW TBA	ENC-P-SDL-T-01
3	1	CONNECTOR: RJ45 SOCKET	WEIDMULLER 1018790000	EC-C-001
4	1	CONNECTOR: USB SOCKET	WEIDMULLER 1018840000	EC-C-002
5	1	CONNECTOR: 15 PIN D TYPE PANEL MTG SKT.	FCT FWD FISSA	EC-C-024
6	1	DISPLAY: TOUCHSCREEN	IMPULSE IDK-1108R-455VA1E	CDMP-210-DISP
7	4	BRACKET: DISPLAY FIXING	PROTEA SDL-T-08-001	SDL-T-08-001

ITEM	QTY	DESCRIPTION	PROTEA STOCK NO
21	4	SCREW: M6 x 16mm PAN HEAD, bzp	SRDF-022
22	4	CUP WASHER BLACK TD SUIT M6 SCREW	SRDF-022
23	2	SCREW: UNC 4-40 x 6 mm, SKT HD, St.St.	UNC-4-40-6-S-SS
24	2	WASHER: M3, St.St.	M3-W-SS
25	12	NUT: M4, St.St.	NUT-M4-SS
26	12	WASHER: M4, St.St.	M4-W-SS

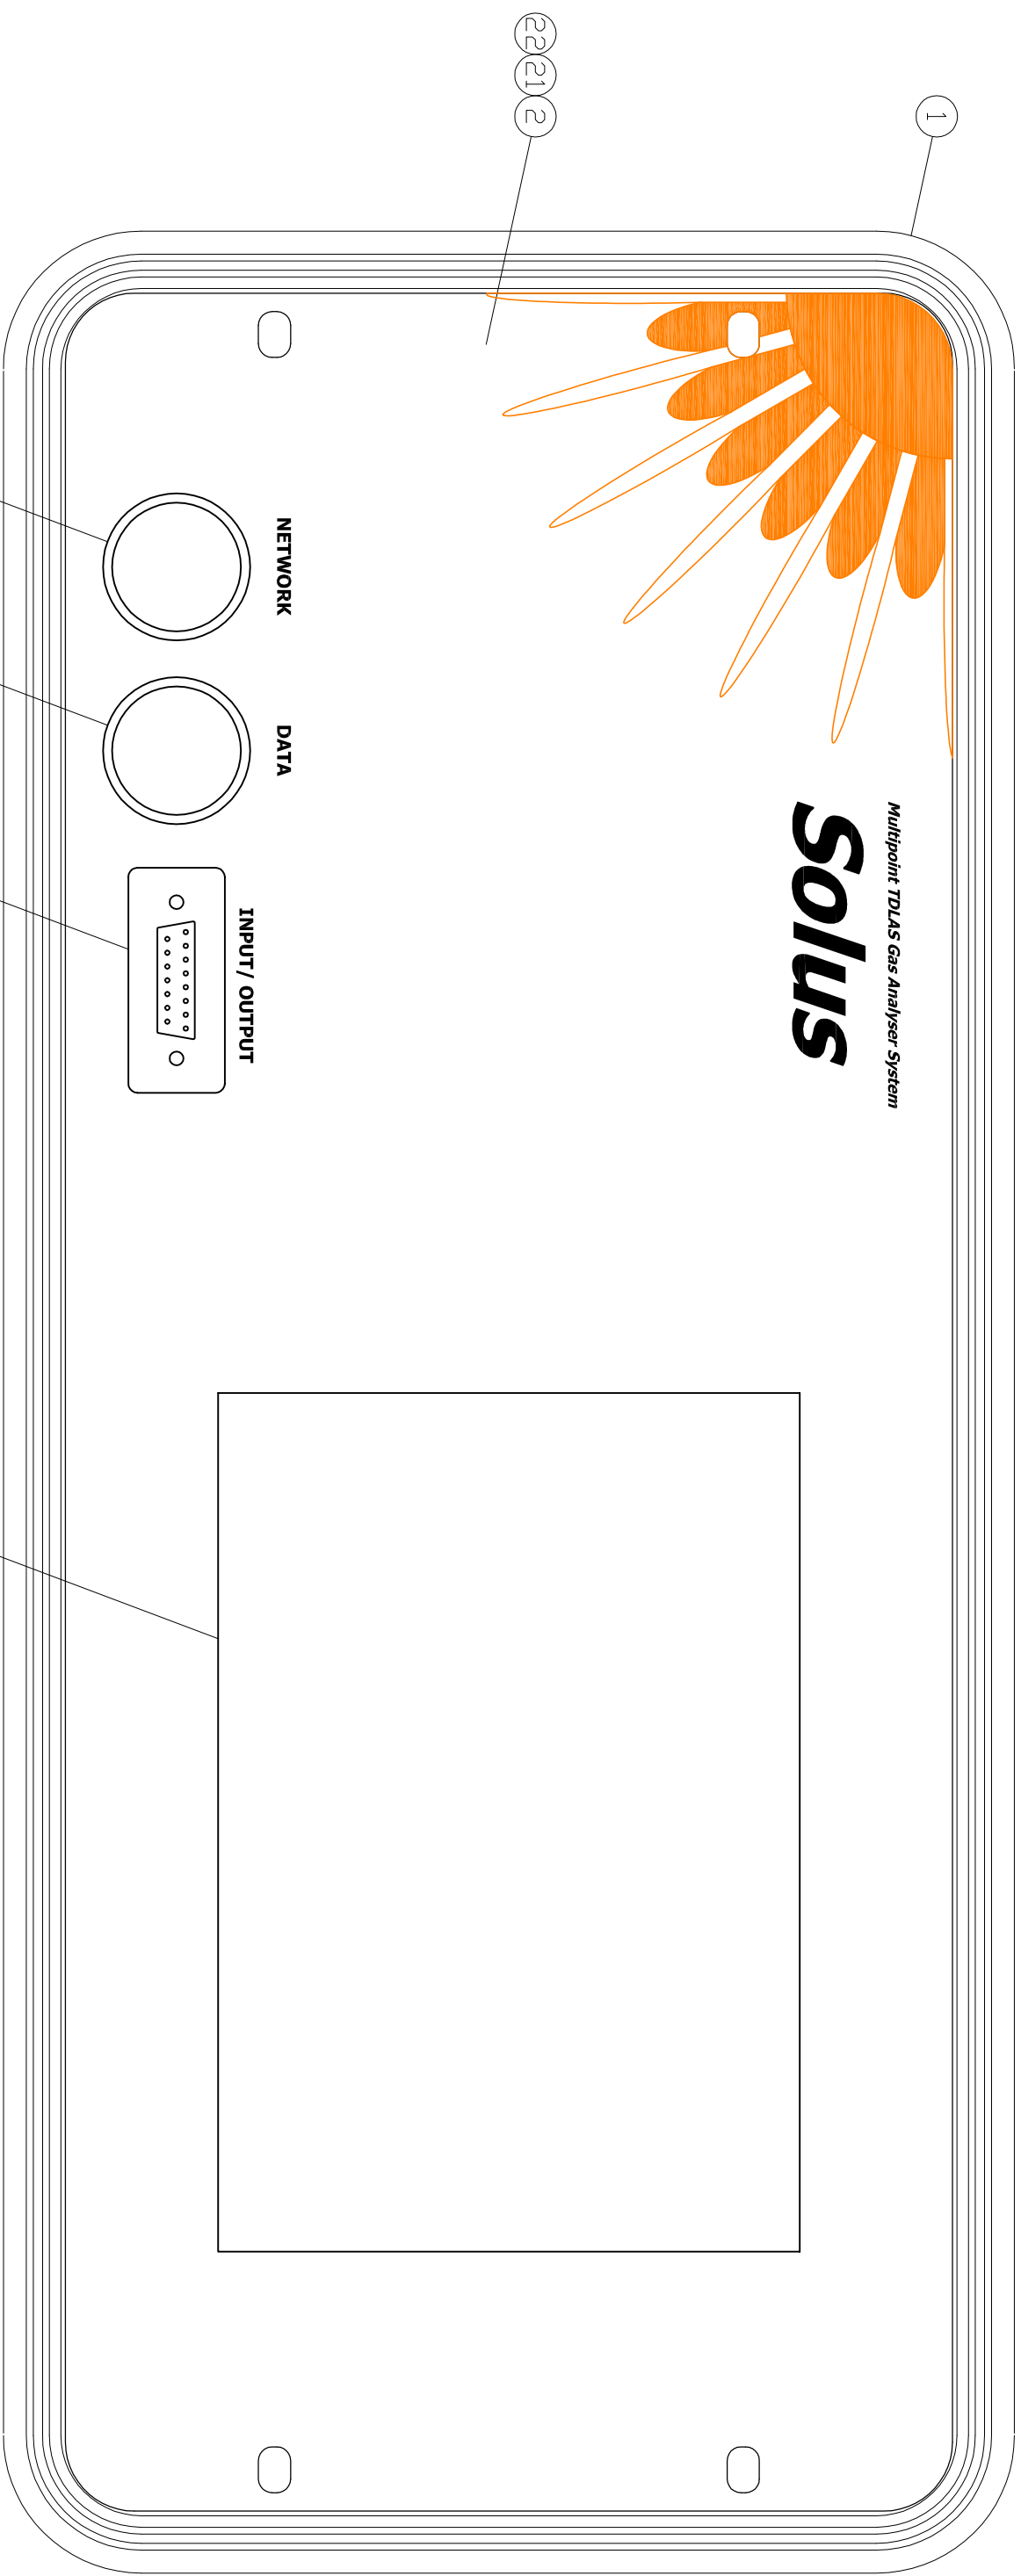

TITLE: MULTIPPOINT TDLAS GAS ANALYSER: FRONT PANEL DETAIL


PROJECT: SOL-T DRAWING No: SOL-T-02-001 SHEET 1 OF 1

NOTES

- PANEL HAS WELD STUDS ON THE REAR FOR THE DISPLAY BRACKET FIXINGS.
- THE DISPLAY IS SECURED TO THE FRONT PANEL BY THE DISPLAY FIXING BRACKETS.

REFERENCE DRAWINGS:

- SDL-T-01-001: GENERAL ARRANGEMENT
- SDL-T-02-002: REAR PANEL
- SDL-T-03-001: P&ID

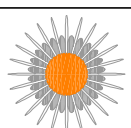

**Protea**  
technology leadership  
in measurement solutions

Protea Limited  
101 The Courtyard  
Radway Green Venture Park  
Cheshire, CW2 5PR, UK  
Tel: +44 (0)1270 872000  
[www.protea.ltd.uk](http://www.protea.ltd.uk)

THIS DRAWING IS COPYRIGHT AND ISSUED ON CONDITION IT IS NOT COPIED, REPRODUCED, OR DISCLOSED TO A THIRD PARTY WITHOUT THE WRITTEN CONSENT OF PROTEA LTD.  
ALL DIMENSIONS IN MILLIMETRES UNLESS OTHERWISE STATED.



TOLERANCES UNLESS OTHERWISE STATED

- X = +/- 1.0
- XX = +/- 0.5
- XXX = +/- 0.1

SCALE: NA

Rev	By	Chk	Date	Change
0	CM	AT	01/12/2015	First Issue