


PARTS

ITEM	QTY	DESCRIPTION	PROTEA STOCK NO
1	1	CASE	ENC-TR-002
2	1	FRONT PANEL	ENC-P-SDL-T-02
3	1	FAN 40 x 40mm	EC-FA-A-4040
4	1	FAN FILTER & FINGER GUARD FOR 40 x 40mm FAN	EC-FA-F-4040
5	1	TYPE/SERIAL NO LABEL	TBA
6	10	CONNECTOR, 8 mm Tube ID 1/8" BSP PARALLEL	FTG-PVDF-8-002
7	4	BULKHEAD UNION 8mm OD TO 6mm OD TUBE, St.St.	FTG-6-059
8	4	BULKHEAD RETAINER FOR 8mm B/H UNION	FTG-6-011
9	1	SWITCH, ROCKER, DPST, RED NEON (0 & 1)	EC-S-003
10	1	CONNECTOR: IEC FUSED FILTER PANEL MTG	EC-PFM-01
11	1	FUSE: 2 A, 20 x 5 mm, SLOW (T), LBC	FUSE-2A-20x5-T-LBC

PARTS

ITEM	QTY	DESCRIPTION	PROTEA STOCK NO
21	4	SCREW: M6 x 16mm PAN HEAD, bzp with black cup washer	SRDF-022
22	4	SCREW M3 x 12mm, CSK, St.St.	M3-12-CSK-SS
23	4	NUT M3, St.St.	NUT-M3-SS
24	4	SCREW: M4 x 8mm, BUTTON HEAD, St.St.	M4-8-B-SS

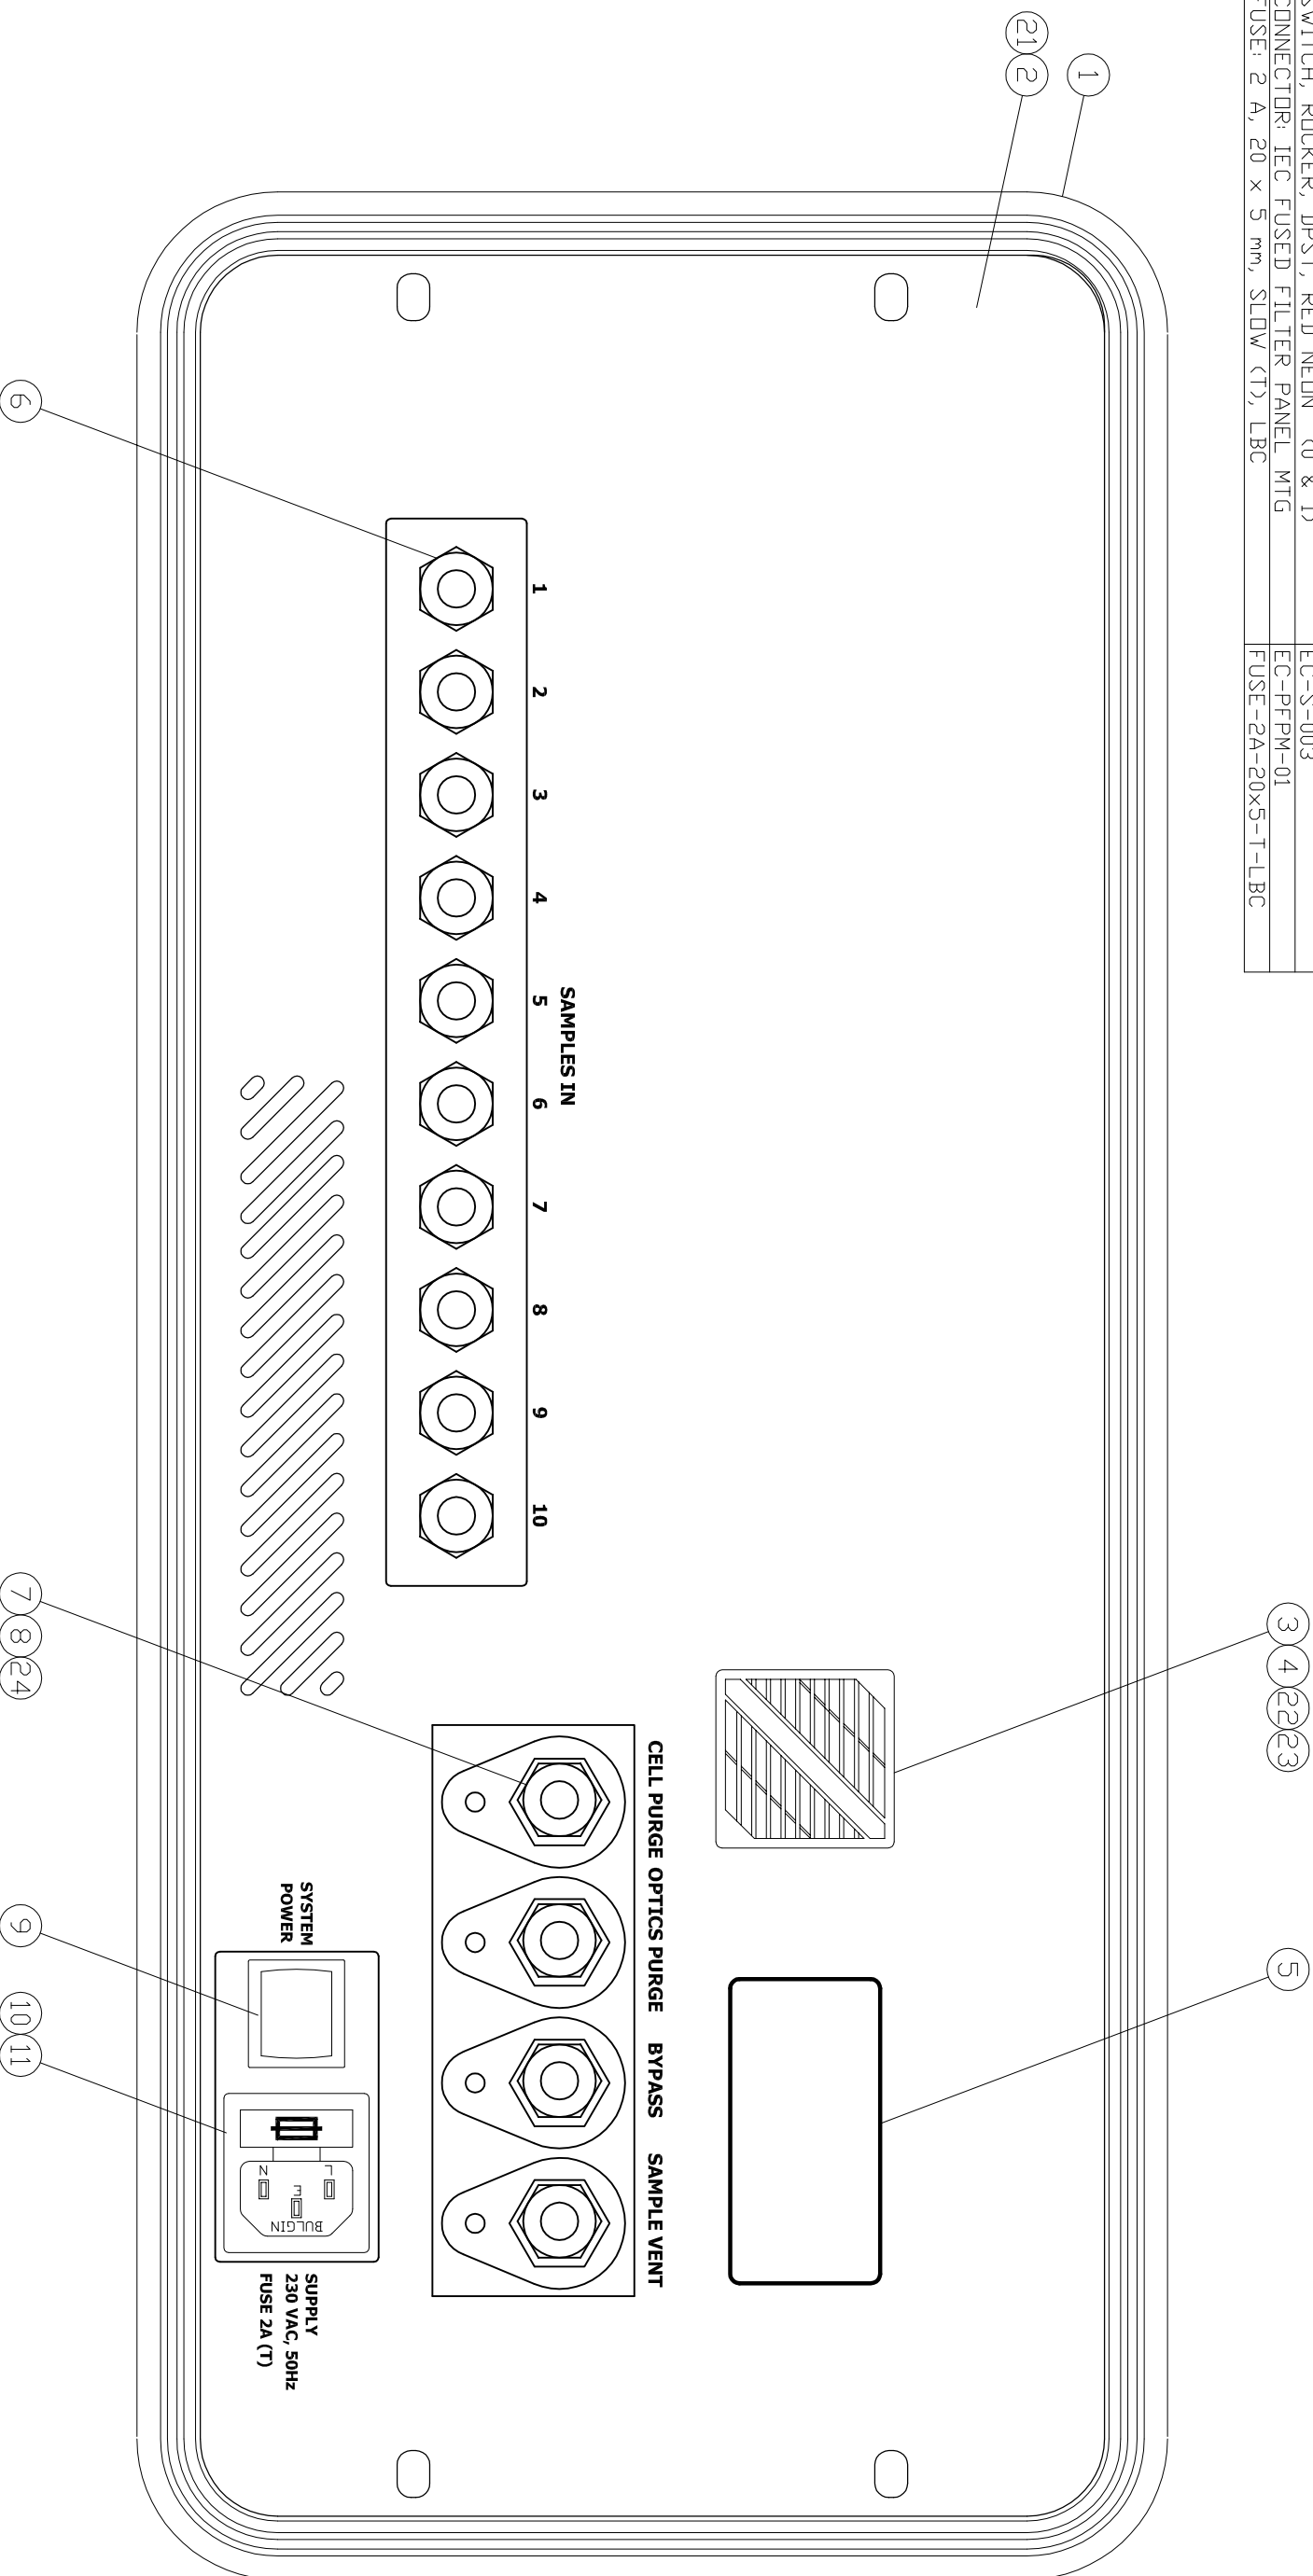

TITLE: MULTIPPOINT TDLAS GAS ANALYSER: REAR DETAIL

PROJECT: SOL-T

DRAWING No: SOL-T-02-002 SHEET 1 OF 1

 
NOTES
1: CONNECTIONS ARE FIXED TO THE INTERNAL BASEPLATE, THE REAR COVER HAS CUT-DUTS THAT FIT ROUND THESE.

2. COLOUR RAL 7035.

3. TEXT DRANGE.

REFERENCE DRAWINGS:

SDL-T-01-001: GENERAL ARRANGEMENT
SDL-T-02-001: FRONT PANEL DETAIL
SDL-T-03-002: P&ID




Protea

technology leadership
in measurement solutions

Protea Limited
101 The Courtyard
Radway Green Venture Park
Radway Green, Crewe,
Cheshire, CW2 5PR, UK
Tel: +44 (0)1270 872000
www.protea.ltd.uk

 THIS DRAWING IS COPYRIGHT AND ISSUED ON CONDITION IT IS NOT COPIED, REPRODUCED, OR DISCLOSED TO A THIRD PARTY WITHOUT THE WRITTEN CONSENT OF PROTEA LTD.
ALL DIMENSIONS IN MILLIMETRES UNLESS OTHERWISE STATED.



THIRD ANGLE PROJECTION

TOLERANCES UNLESS OTHERWISE STATED

X = +/- 1.0

XX = +/- 0.5

XXX = +/- 0.1

SCALE: NA

Rev	By	Chk	Date	Change
0	CM	AT	01/12/2015	First Issue
				Change